


MAIN LT PANEL
LOC: ELECTRIC ROOM
CONNECTED LOAD: 462KW/578KVA

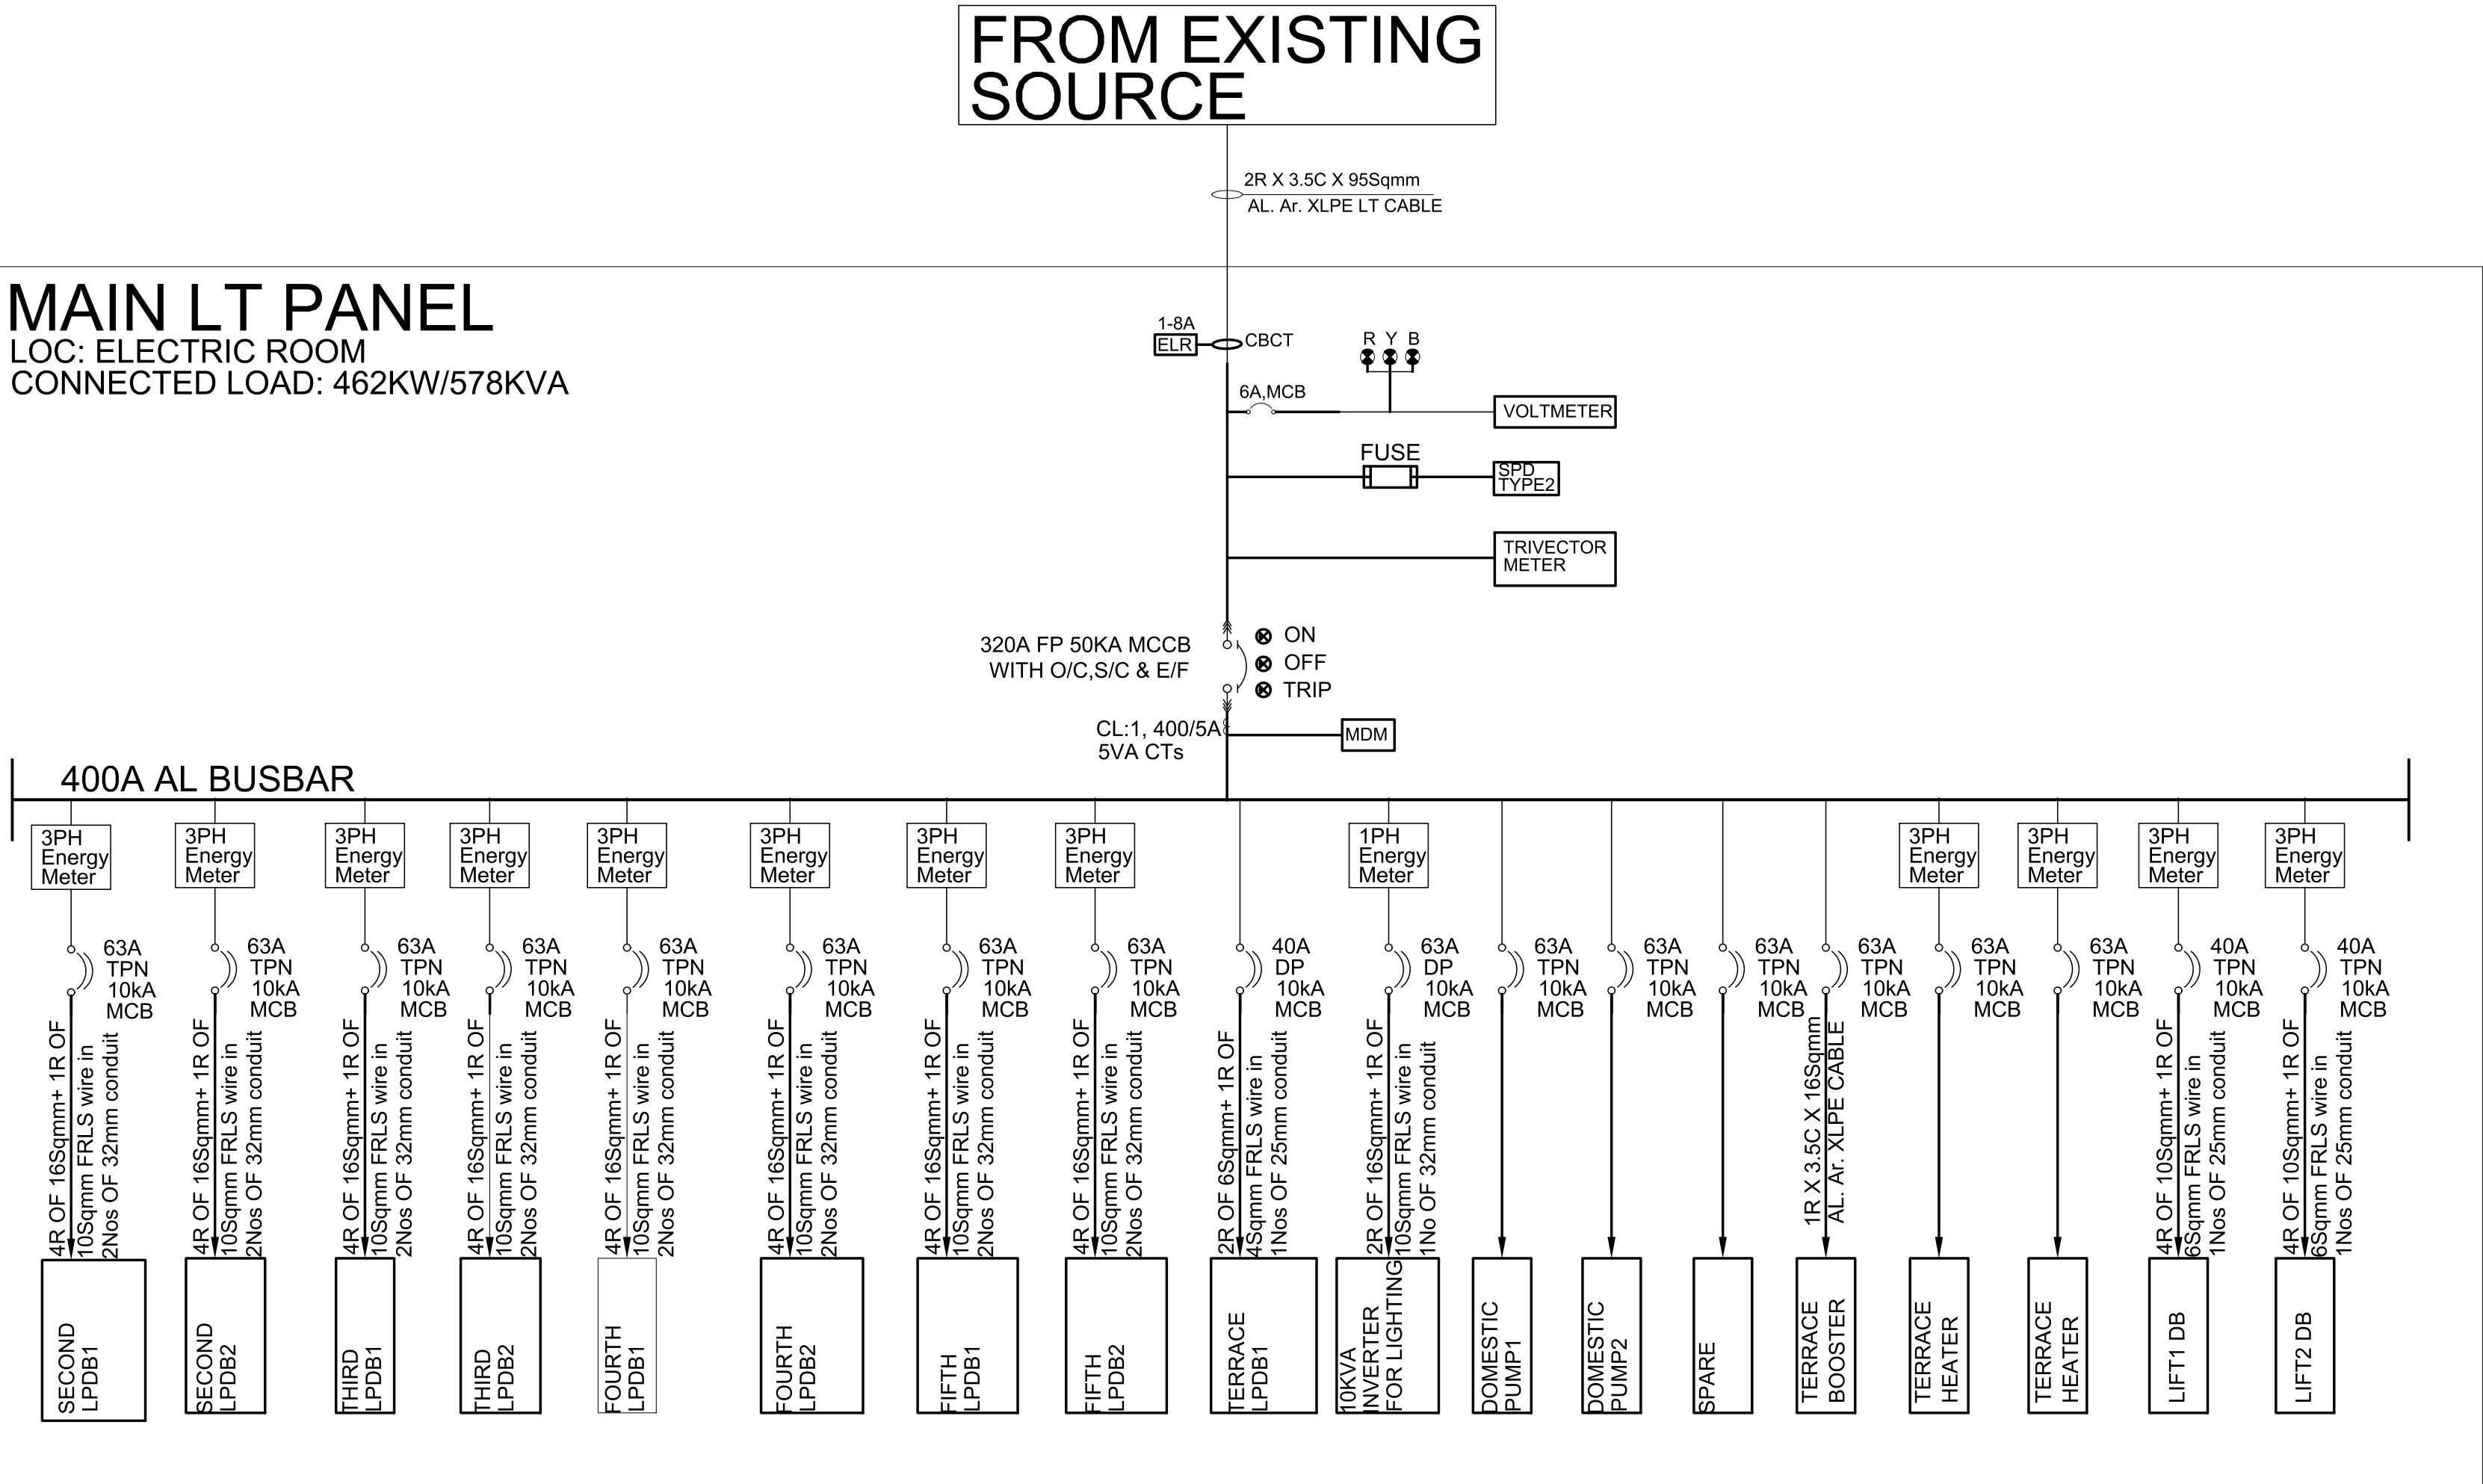

REV NO	DATE	DESCRIPTION
DRAWING ISSUED FOR 00Nos		
APPROVAL PURPOSE		
TENDER PURPOSE		
STUDY PURPOSE		
EXECUTION PURPOSE		

ELECTRICAL

CLIENT :
NLSIU.
NATIONAL LAW SCHOOL OF
INDIA UNIVERSITY.
Bangalore.

JOB TITLE :
PROPOSED EXTENSION OF
LEARNING CENTRE AT NLSIU, BANGALORE.

DRAWING: SINGLE LINE DIAGRAM	
SCALE : 1:100	DEALT : Kumar
DATE : 04-08-2022	DRAWN : Ajay
ISSUED : 17-08-2022	CHECKED : Meghal S Karekar

KAREKAR & ASSOCIATES
ARCHITECTS, INTERIOR DESIGNERS AND
STRUCTURAL ENGINEERING CONSULTANTS
#282, Ground Floor, 14th Cross,
HIG Dollars Colony, RMV 2nd Stage,
Bengaluru-560094

DRG NO: NLSIU / LEARNING CEN / ELE/ SLD	R1
--	----

COPY RIGHT :
Drawings and specifications as instruments of services are the
property of the architect whether the work for which they are
made be executed or not ,and they are not to be used on their
work except by agreement .